

Notes




- This drawing has been produced by Pegasus Group for the client and should not be used for anything outside of its intended purpose. Pegasus Group accept no liability for the misuse of this drawing.
- Drainage design has been developed based on internal layout provided by RES Ltd drawing ref "04886-RES-LAY-DR-PT-003 Rev 4" and topographical survey.
- Drainage layout is subject to change as part of detailed design development and third party stakeholder approvals.

Key

- Existing ground
- Pond base
- Pond maintenance access track (3m minimum)
- Filter drain (150mm perforated pipe)
- 150mm drainage pipe

Plan View 1:1000

Pond Sections H1:500 V1:100

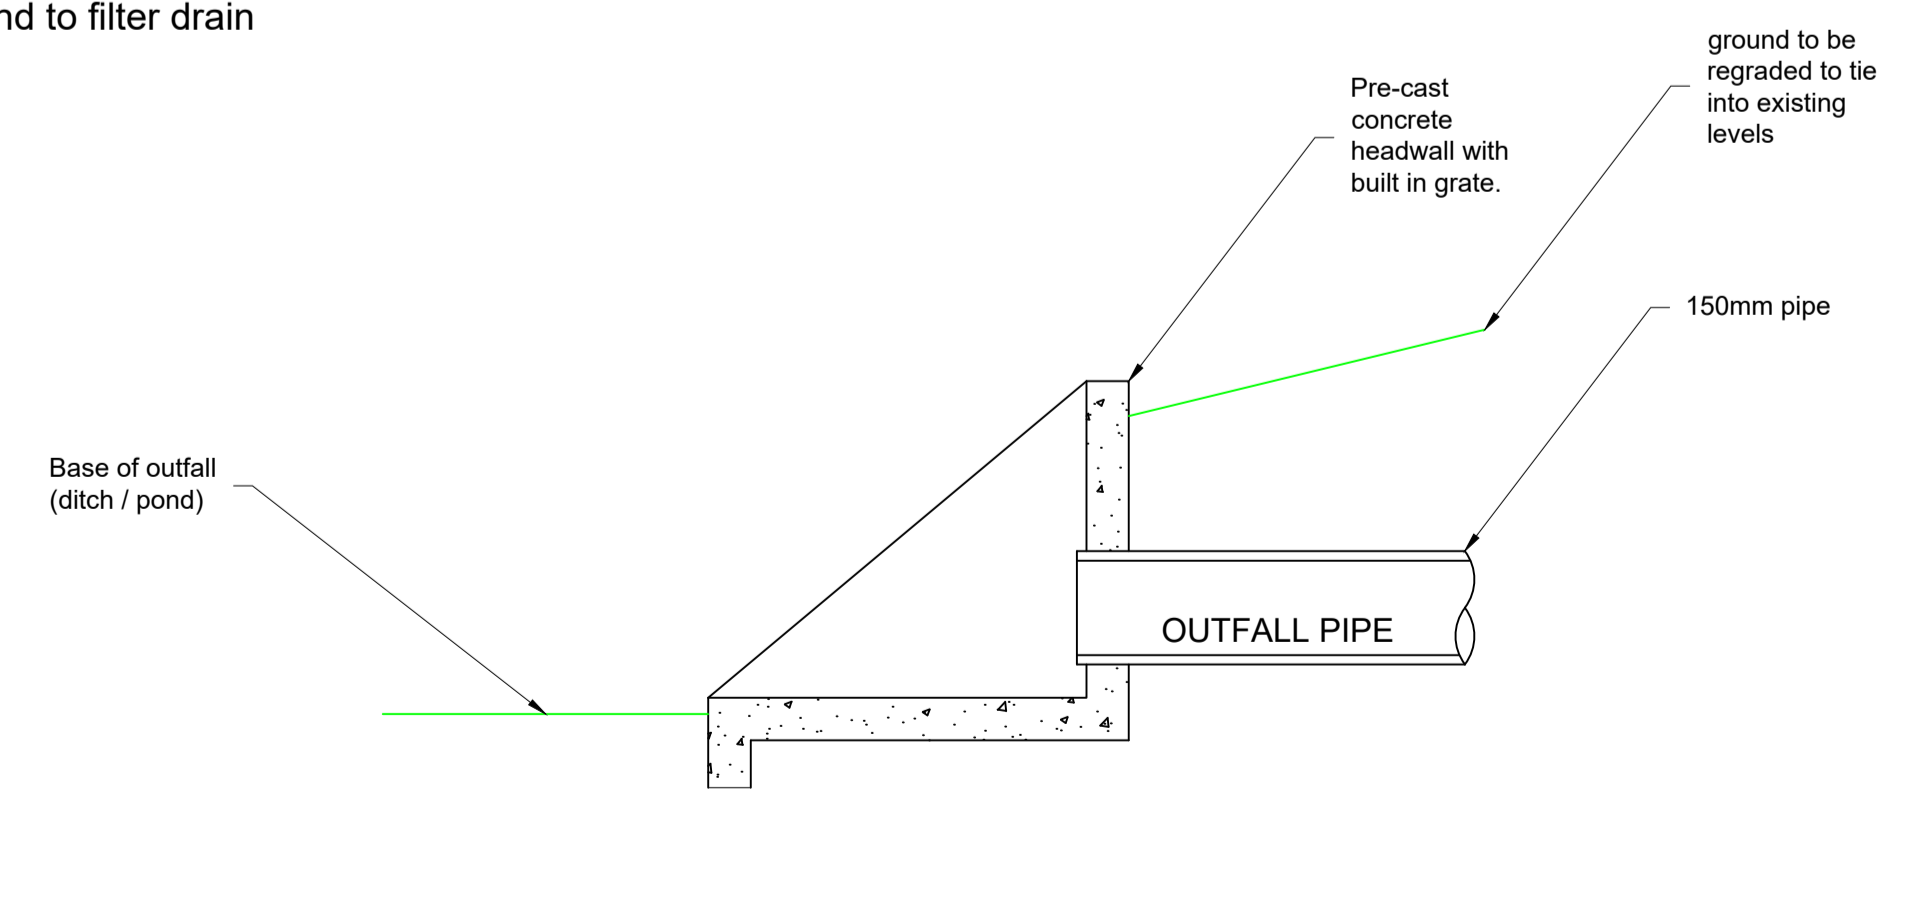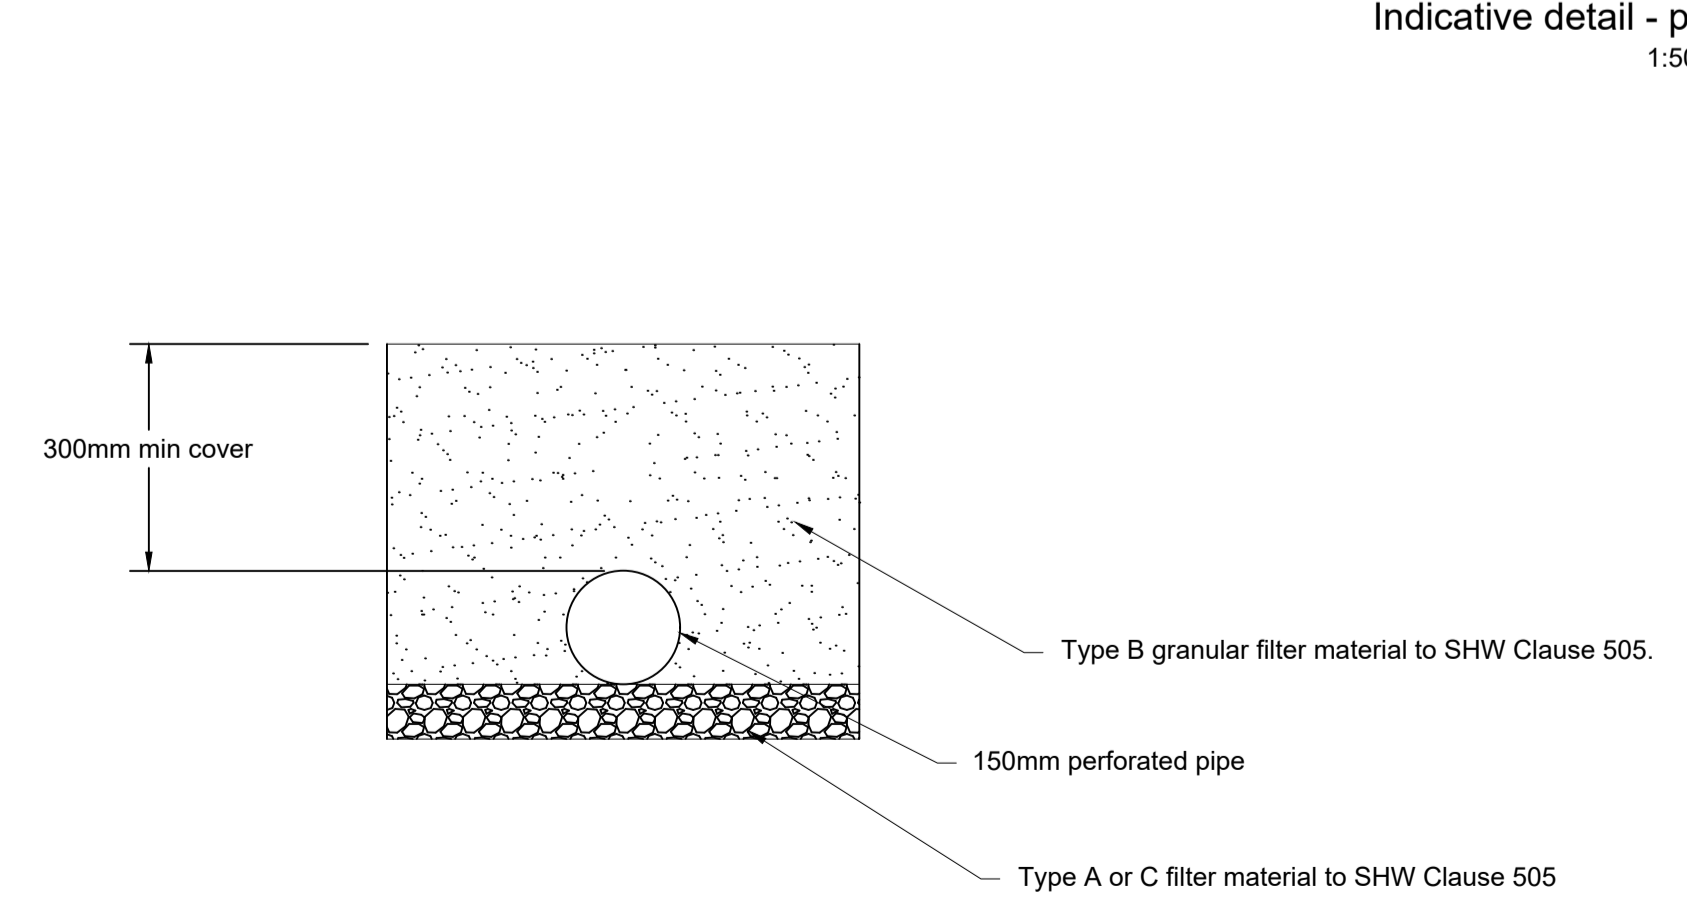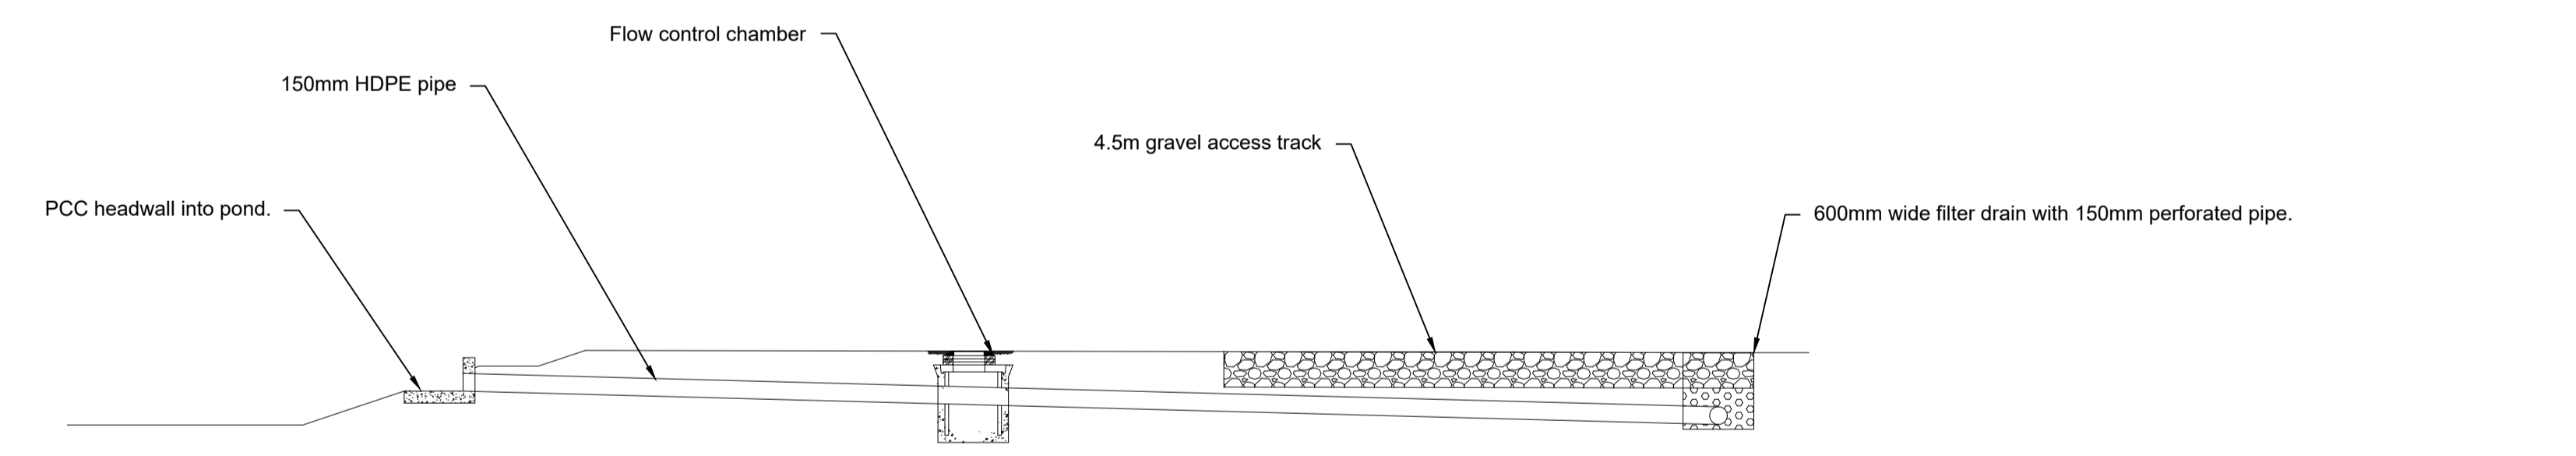

REV	DATE	DESCRIPTION	REVISED BY	APPROVED BY
P5	31.08.23	Minor alteration to notes	LAJ	SAJ
P4	04.03.23	Amended for client comments	LAJ	SAJ
P3	17.07.23	Amended for LLFA comments	LAJ	SAJ
P2	26.04.23	Amended for client comments	HVC	SAJ
P1	04.03.23	First issue	HVC	SAJ

Drainage Design

Varley Solar Farm
 Cromhall, South Gloucestershire

CLIENT:
 RES Ltd

DATE: 4/04/2023 SCALE: AS SHOWN@A1 TEAM/DRAWN BY: HVC APPROVED BY: SAJ

DRAWING NUMBER:
 P22-0915 - PEG - XX - XX - DR - C - 0001 - P5

PEGASUS REF No: P22-0915 DRAWING STATUS: S2

PEGASUS GROUP